


NOTES

1. THIS DRAWING IS TO BE READ IN CONJUNCTION WITH ALL ENGINEERS & ARCHITECTS DRAWINGS FIGURED DIMENSIONS ONLY (NOT SCALING) TO BE USED. WHERE A CONFLICT OF INFORMATION EXISTS OR IF IN ANY DOUBT - 'ASK'.
2. CONSULTANTS TO BE INFORMED IMMEDIATELY OF ANY DISCREPANCIES BEFORE WORK PROCEEDS.
3. EXTERNAL PAVING TO BE LAID TO FALL TOWARDS PROPOSED GULLIES

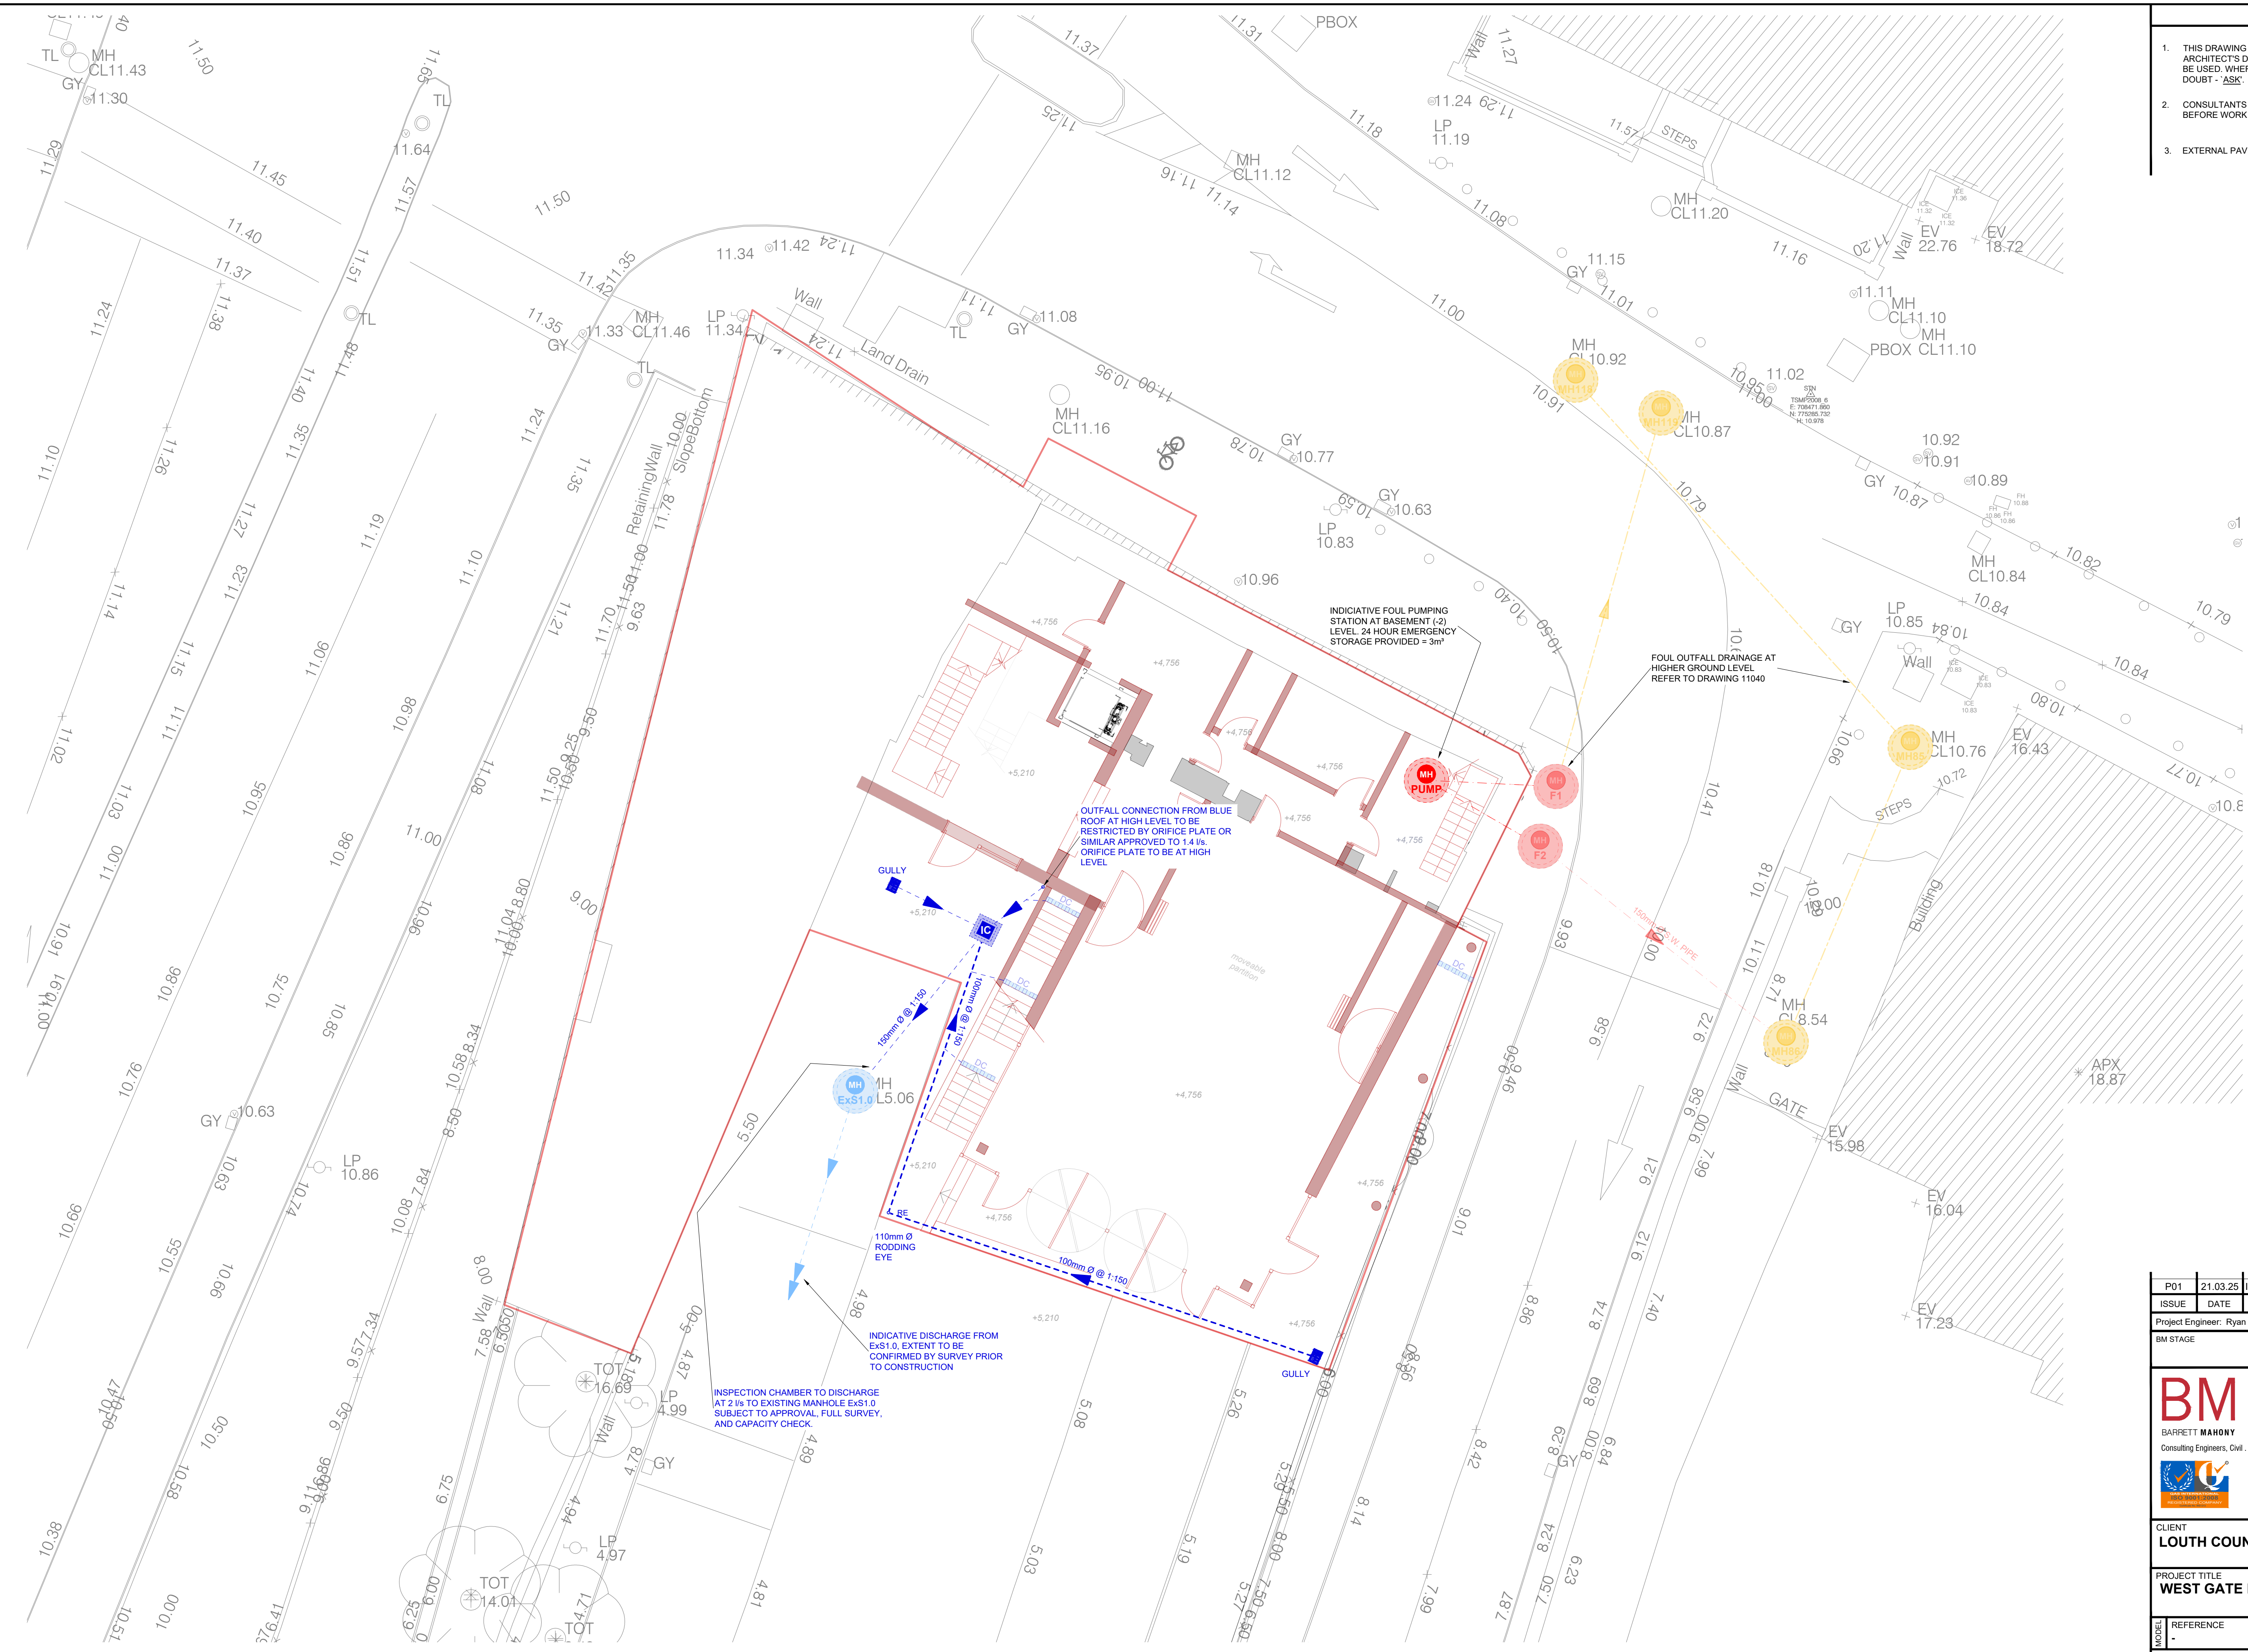

PLAN BASEMENT (-2) FLOOR LEVEL - DRAINAGE LAYOUT

SCALE @ A1: 1:100
SCALE @ A3: 1:200

P01	21.03.25	ISSUED FOR PLANNING	E.C.
ISSUE	DATE	DESCRIPTION	BY
Project Engineer: Ryan Hutchinson		Project Director: Stephen O'Connor	
BM STAGE			
PLANNING			
BM		Dublin Office: Sandwith House, 52-54 Lower Sandwith Street, Dublin 2, Ireland. Tel: (01) 677 3200 Fax: (01) 677 3164 London Office: 5th Floor, Mill House, 8 Mill Street, London SE1 2BA, United Kingdom Tel: (0044) 20 3750 3530	
BARRETT MAHONY Consulting Engineers, Civil - Structural - Project Management E-mail: bmce@bmce.ie Web: www.bmce.ie			
CLIENT			
LOUTH COUNTY COUNCIL			
PROJECT TITLE		BM PROJECT No.	
WEST GATE HOUSE		24284	
REFERENCE	SUITABILITY	REVISION	
-	-	-	
DRAWING TITLE			
PROPOSED BASEMENT DRAINAGE LAYOUT			
DWG	DRAWING REFERENCE	STATUS	REVISION
DGA-00-94-00-ZR-BMCE-CE-11030	-	-	P01