


NOTES

- THIS DRAWING IS TO BE READ IN CONJUNCTION WITH ALL ENGINEERS & ARCHITECTS DRAWINGS FIGURED DIMENSIONS ONLY (NOT SCALING) TO BE USED. WHERE A CONFLICT OF INFORMATION EXISTS OR IF IN ANY DOUBT - 'ASK'.
- CONSULTANTS TO BE INFORMED IMMEDIATELY OF ANY DISCREPANCIES BEFORE WORK PROCEEDS.

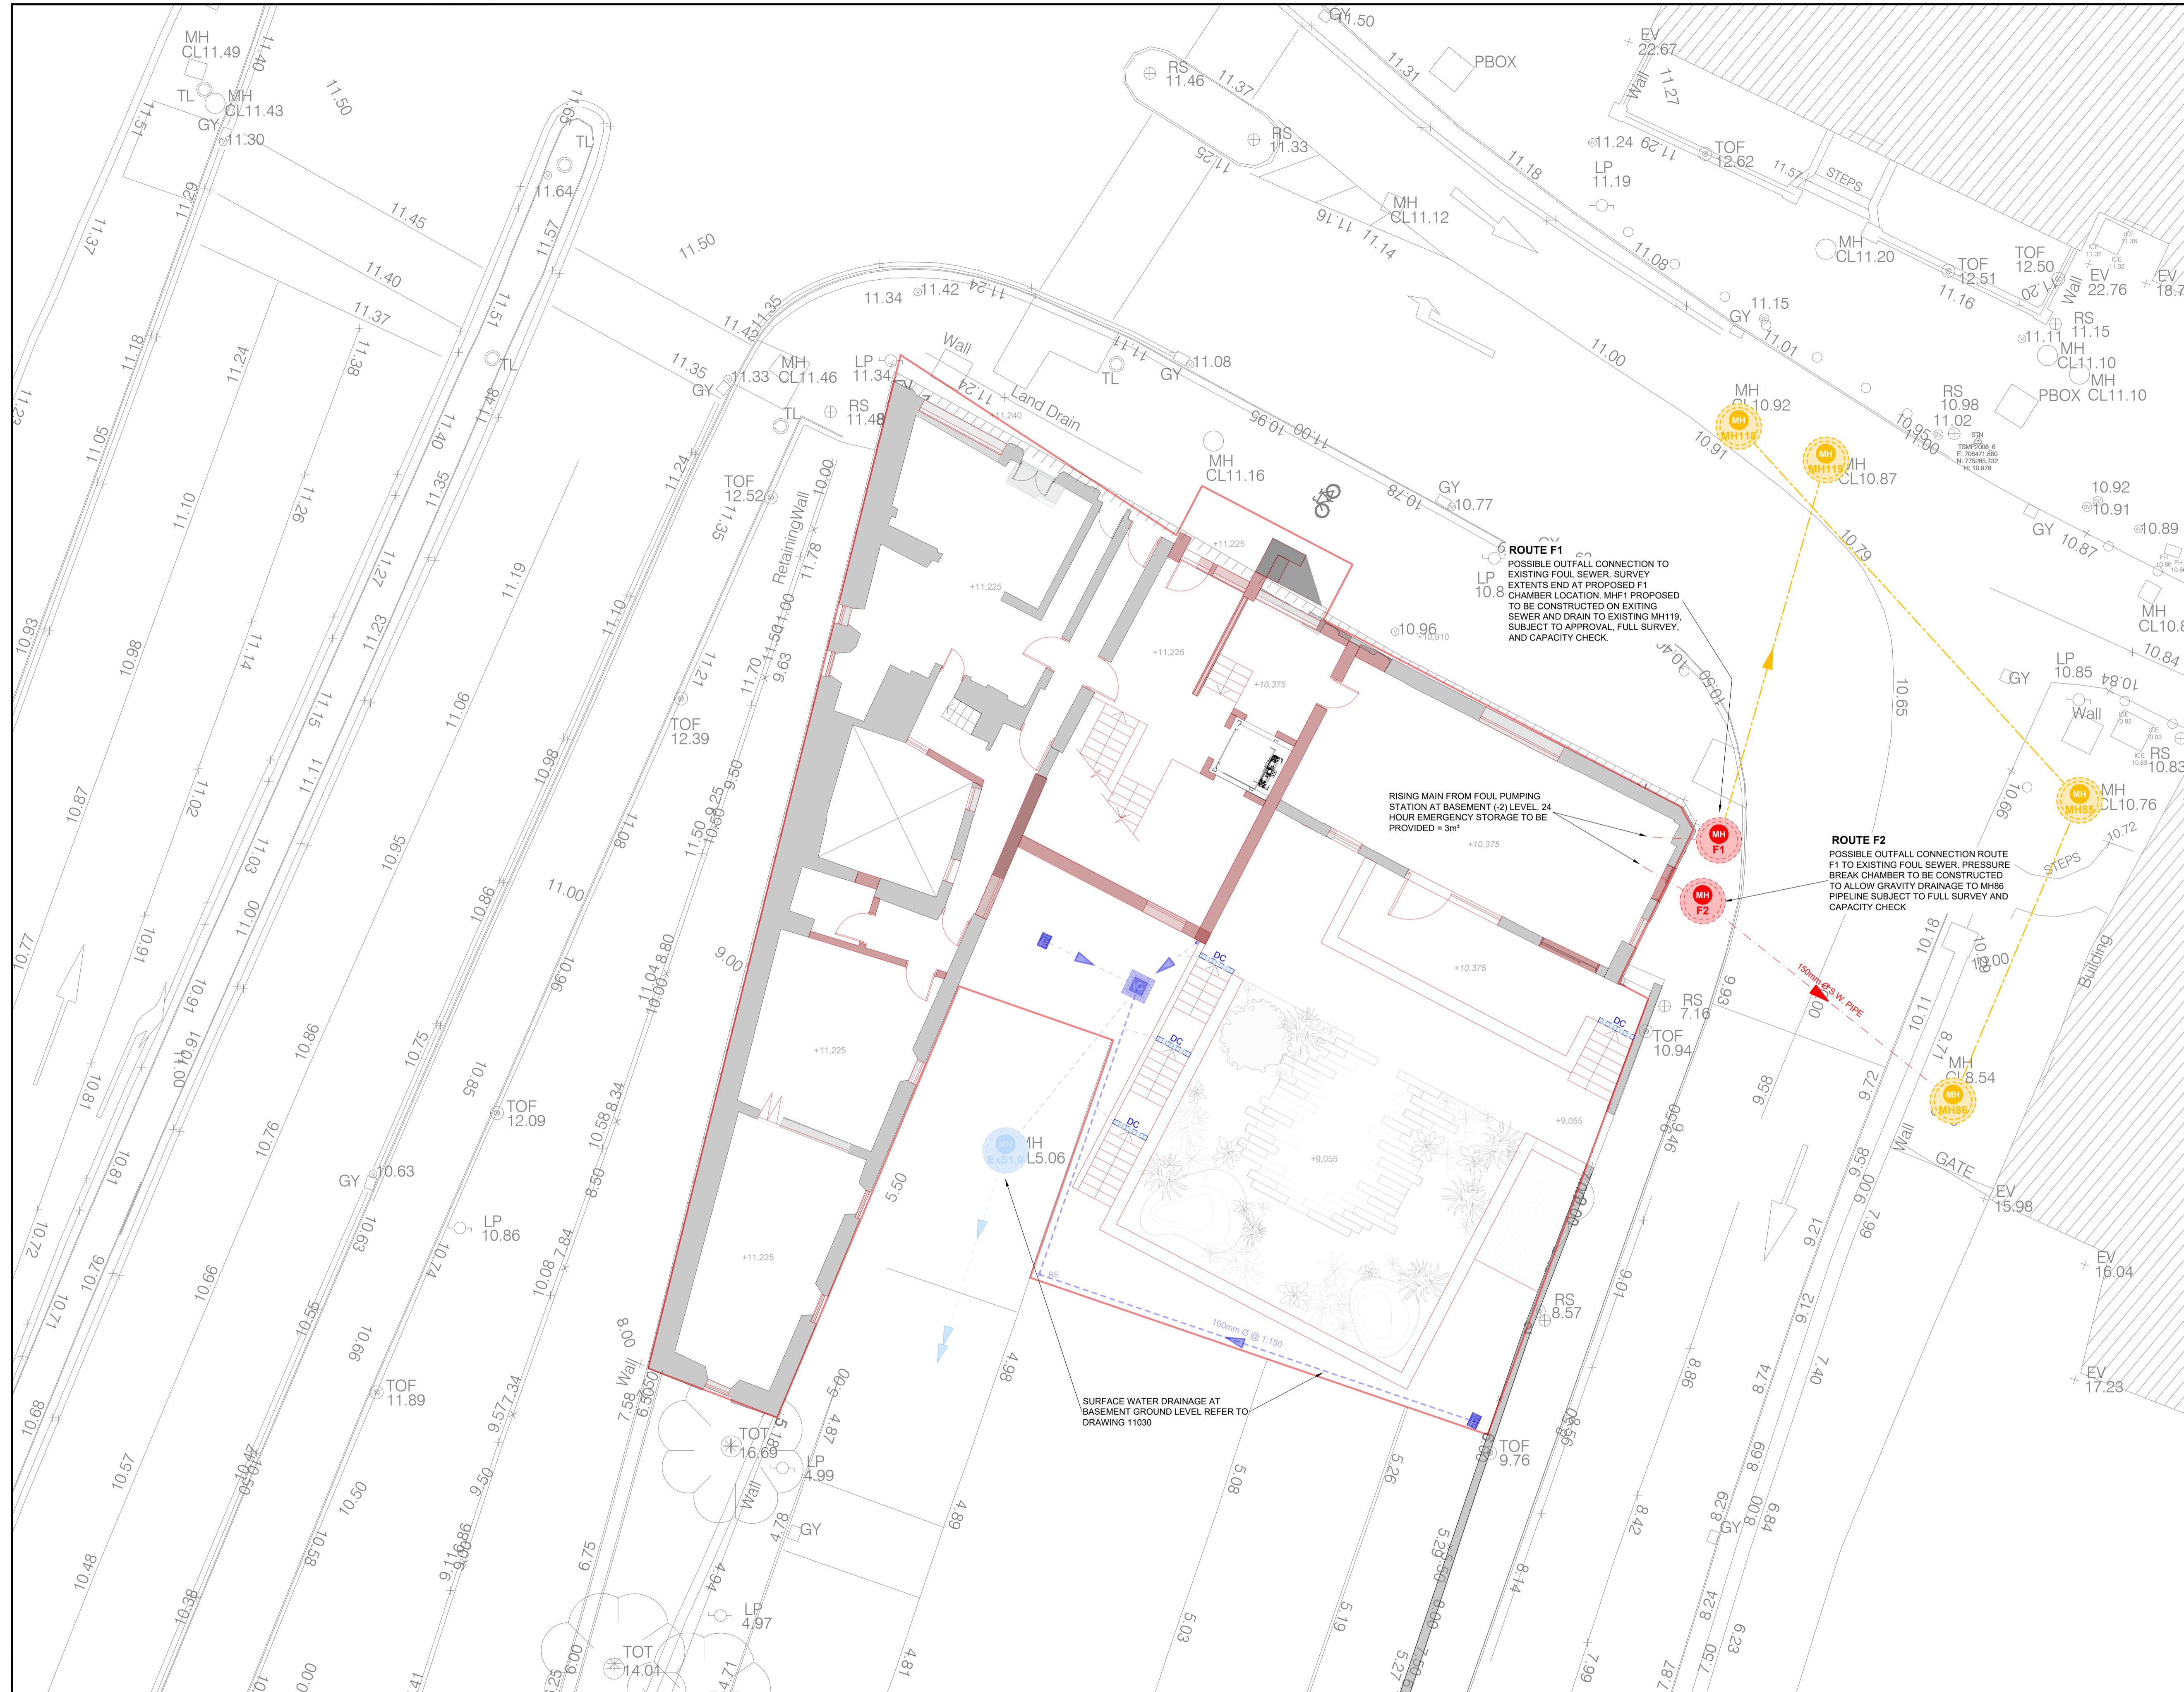

PLAN GROUND FLOOR LEVEL - DRAINAGE LAYOUT

SCALE @ A1: 1:100
SCALE @ A3: 1:200

P01	21.03.25	ISSUED FOR PLANNING	E.C.
ISSUE	DATE	DESCRIPTION	BY
Project Engineer: Ryan Hutchinson		Project Director: Stephen O'Connor	
BM STAGE			
PLANNING			
BM		Dublin Office: Sandwith House, 52-54 Lower Sandwith Street, Dublin 2, Ireland. Tel: (01) 677 3200 Fax: (01) 677 3154 London Office: 5th Floor, Mill House, 8 Mill Street, London SE1 2BA, United Kingdom Tel: (0044) 20 3750 3530 Consulting Engineers, Civil, Structural, Project Management. E-mail: bmce@bmce.ie Web: www.bmce.ie	
CLIENT LOUTH COUNTY COUNCIL			
PROJECT TITLE WEST GATE HOUSE		BM PROJECT No. 24284	
REFERENCE	SUITABILITY	REVISION	
DRAWING TITLE PROPOSED GROUND LEVEL DRAINAGE AND WATERMAIN LAYOUT			
DWG	DRAWING REFERENCE DGA-00-94-00-ZZ-DR-BMCE-CE-11040	STATUS -	REVISION P01